














**LEGEND**


-  SINGLE SWITCHED SOCKET OUTLET
-  SINGLE SWITCHED SOCKET OUTLET
-  FUSED SPUR OUTLET
-  16A ISOLATOR (IP65 RATED)
-  WARM AIR HAND DRYER
-  FLOOR BOX CONTAINING 2 x SOCKETS, 1 x DATA & 1 x TELEPHONE OUTLETS
-  16 WAY TP&N DISTRIBUTION BOARD
-  DATA OUTLET POINT
-  TELEPHONE OUTLET POINT
-  TELEVISION OUTLET POINT
-  DISABLED ALARM PANEL
-  DISABLED ALARM OVERDOOR INDICATOR LIGHT
-  DISABLED ALARM RESET BUTTON
-  DISABLED ALARM EMERGENCY PULL CORD

**NOTES:**


1. FUSED CONNECTION UNIT FOR BOILER. FINAL POSITION TO BE AGREED WITH VENT INSTALLER. VENTILATION TO TOILETS TO BE OPERATED VIA LOCAL LIGHT SWITCHES. LAUNDRY, TEA BAY & REFUSE FANS TO BE PERMANENTLY ON TRICKLE SPEED, WITH BOOST SWITCH TO INCREASE EXTRACT RATE.
2. POWER SUPPLIES FOR RECEPTION COOLING. POSITION & RATING TO BE CONFIRMED BY AIR-CONDITIONING SUB-CONTRACTOR.
3. FUSED CONNECTION UNIT FOR THE INCOMING BT MAIN SERVICE TO BE ADVISED BY BT.

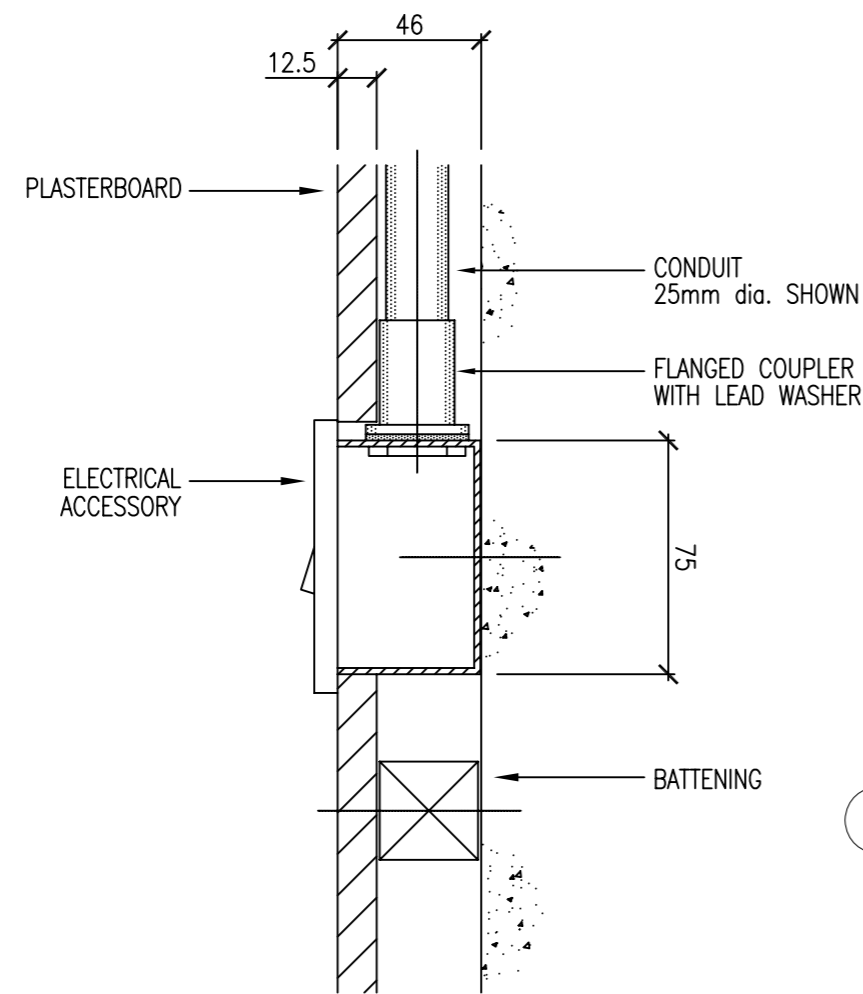

ACCESSORY INSTALLATION DETAIL (Not To Scale)

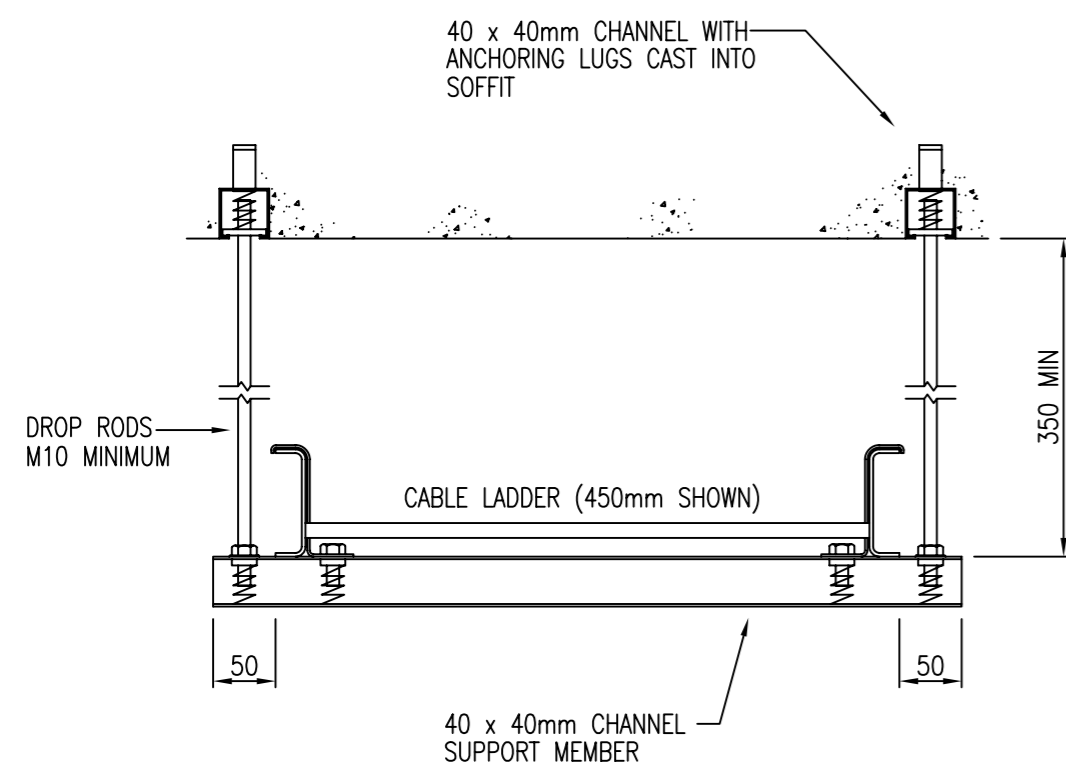

CABLE LADDER SUPPORT DETAIL (Not To Scale)

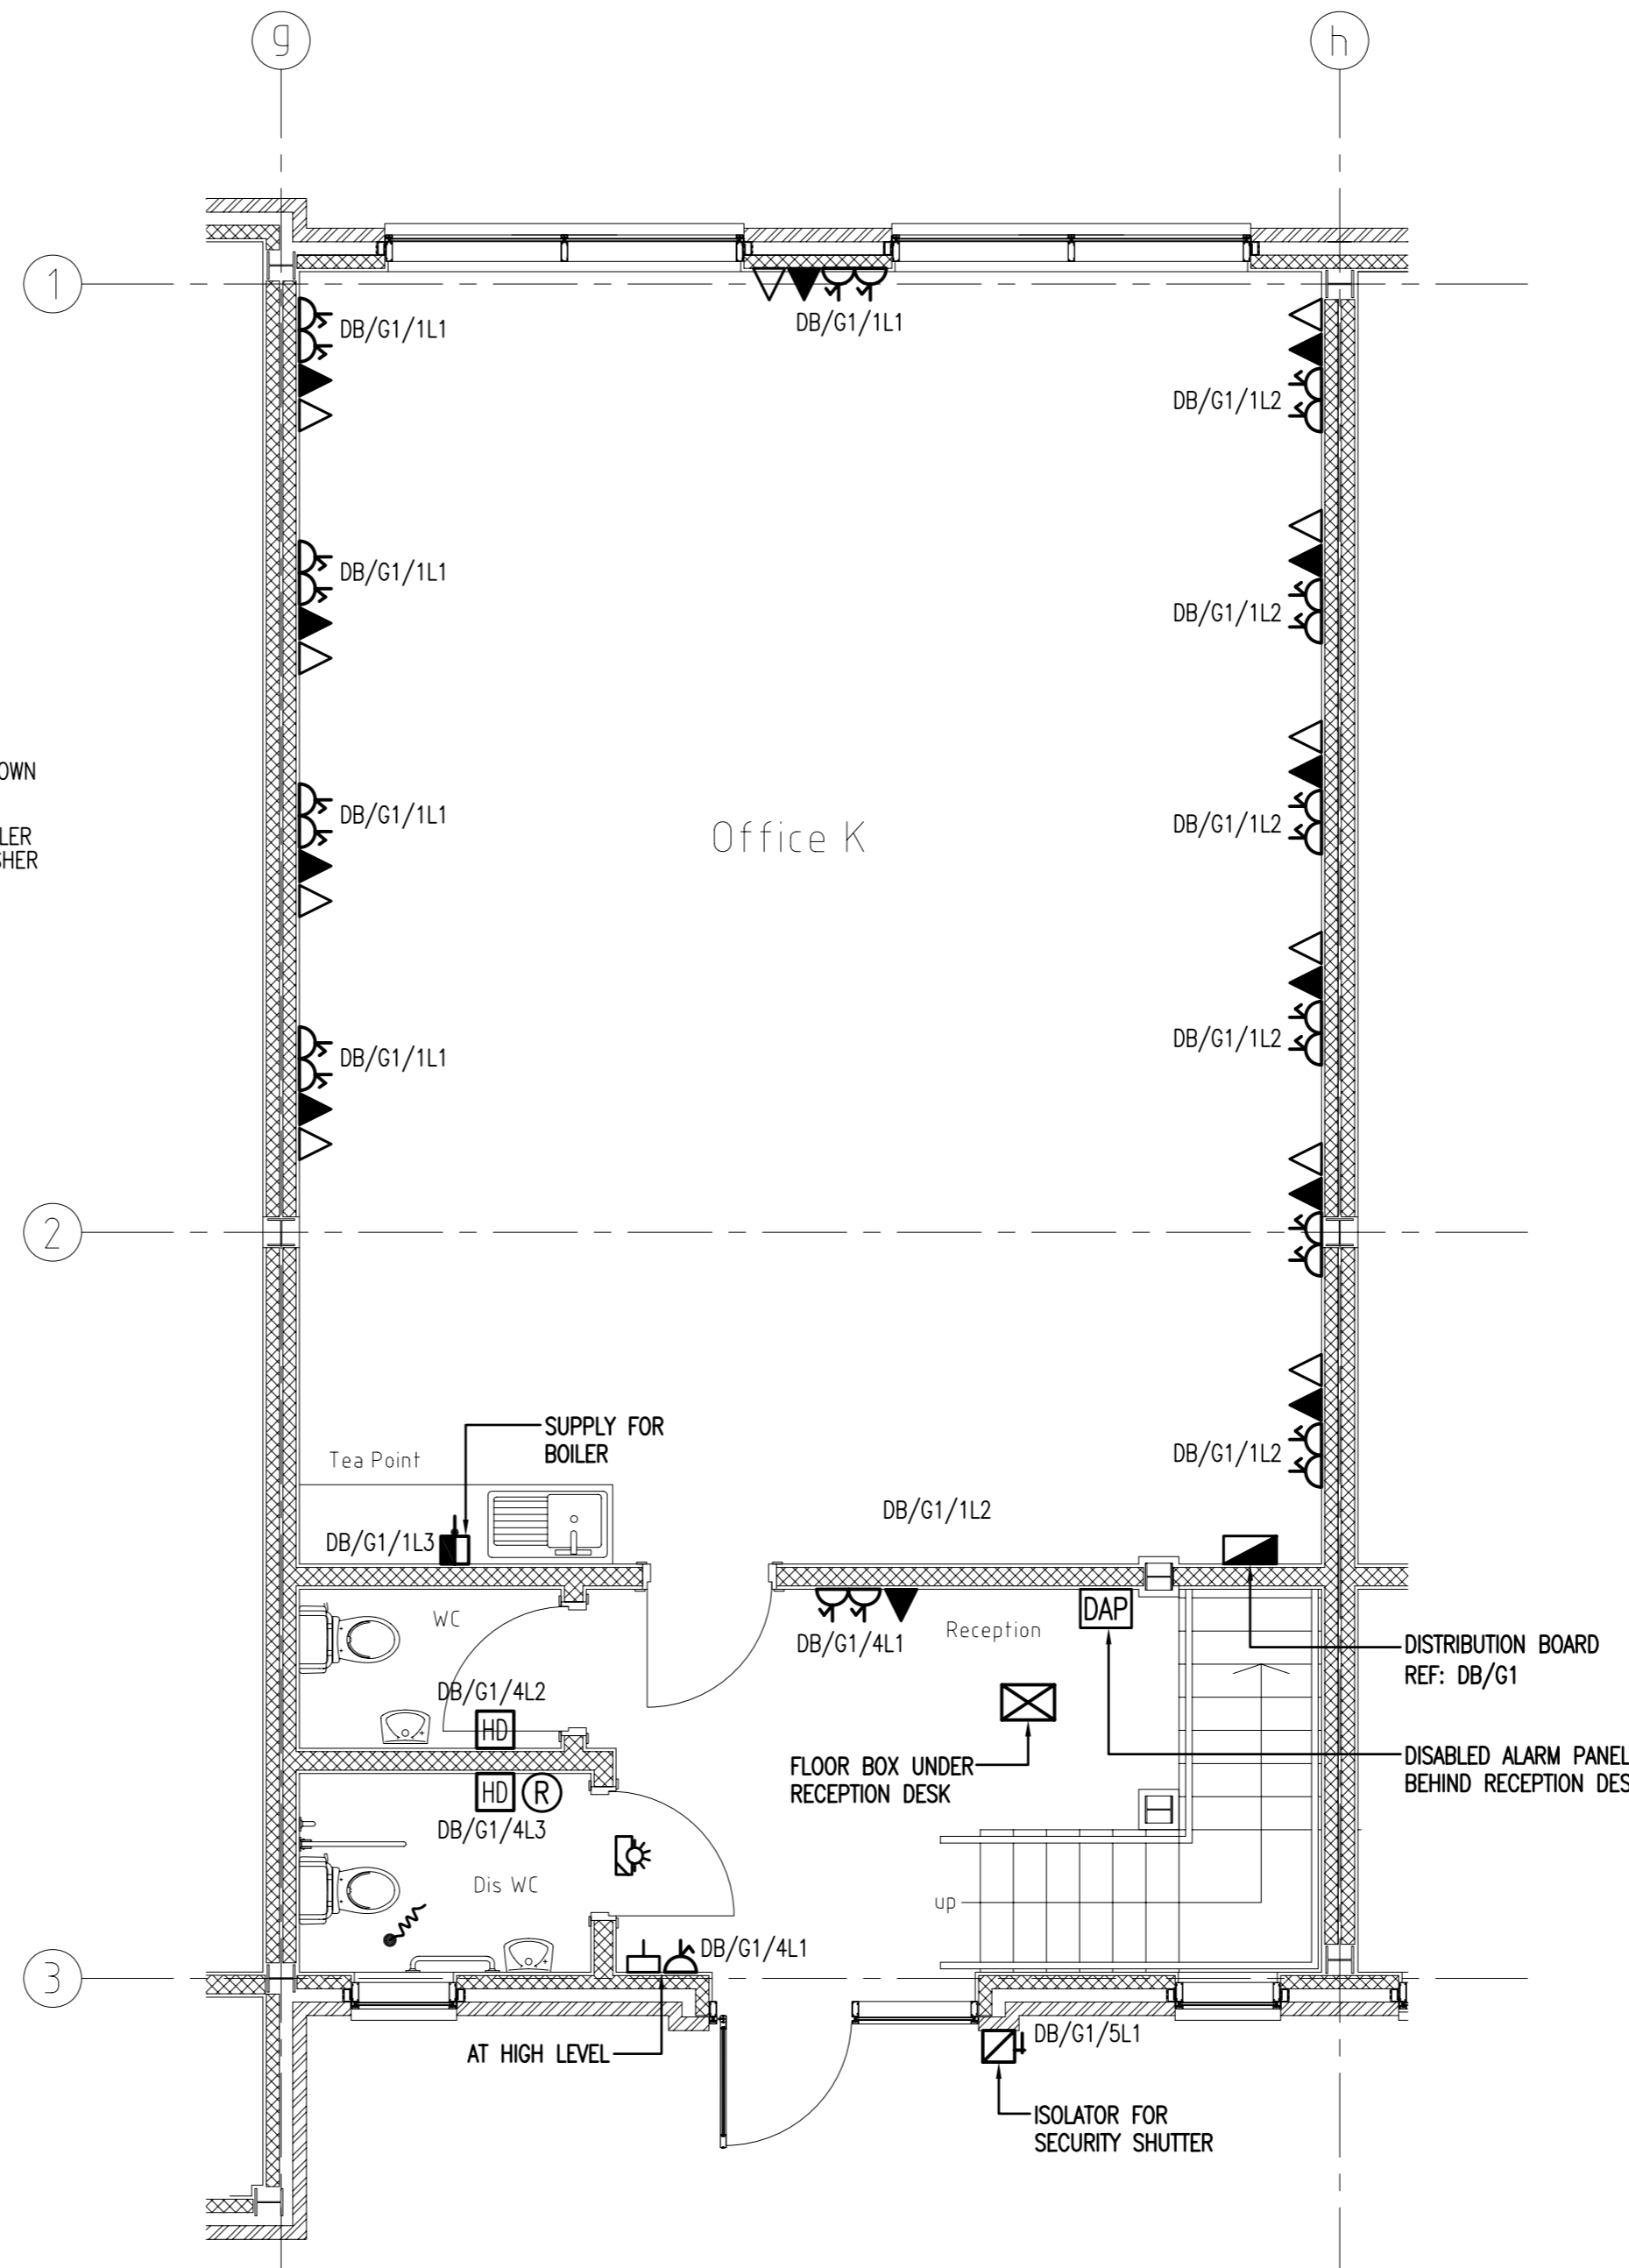

Rev	Date	Description	By
A	12/08/08	ARCHITECTURAL LAYOUT REVISED	AH

**CONSTRUCTION**

Client  
S.C.H. PROPERTIES Ltd.

Job Title  
MERLIN TECHNOLOGY PARK  
READING

Drawing Title  
OFFICE K  
GROUND FLOOR  
SMALL POWER  
& DATA LAYOUT

Drawn	Scale	Checked
Alcad	1:50@A2	P.S.
Date	Client Ref.	Approved
06/07/08	SCH1	M.W.

**ALCAD**  
*Draughting Services*  
29 Instone Road Halesowen West Midlands B63 4SA  
Tel: 07973 117873 Fax: 07970 764146 Email: alan@alcad.co.uk

Drawing No.	Issue
1704/E02	A
Job No.	1704-E02.dwg
SCH03/2008	